 
 


THIS DRAWING IS TO BE READ IN CONJUNCTION WITH ALL RELATED DRAWINGS. ALL DIMENSIONS MUST BE CHECKED AND VERIFIED ON SITE BEFORE COMMENCING ANY WORK OR PRODUCING SHOP DRAWINGS. THE ORIGINATOR SHOULD BE NOTIFIED IMMEDIATELY OF ANY DISCREPANCY. THIS DRAWING IS COPYRIGHT AND REMAINS THE PROPERTY ROGER PARRY & PARTNERS.


 Gas Pipeline

 Dirty water from wash down will be collected in an underground sealed tank, which will be constructed to meet the SSAFO Regulations (Wales) 2010 standards.

 Clean water from roof and clean surfaces to open and stone filled infiltration trenches and a piped system each side of building.

The clean and foul water drainage systems will be kept separate in order to ensure no pollution incident occurs to the environment.

At the wash down stage clean water systems around the yard will be switched to underground dirty water tank.

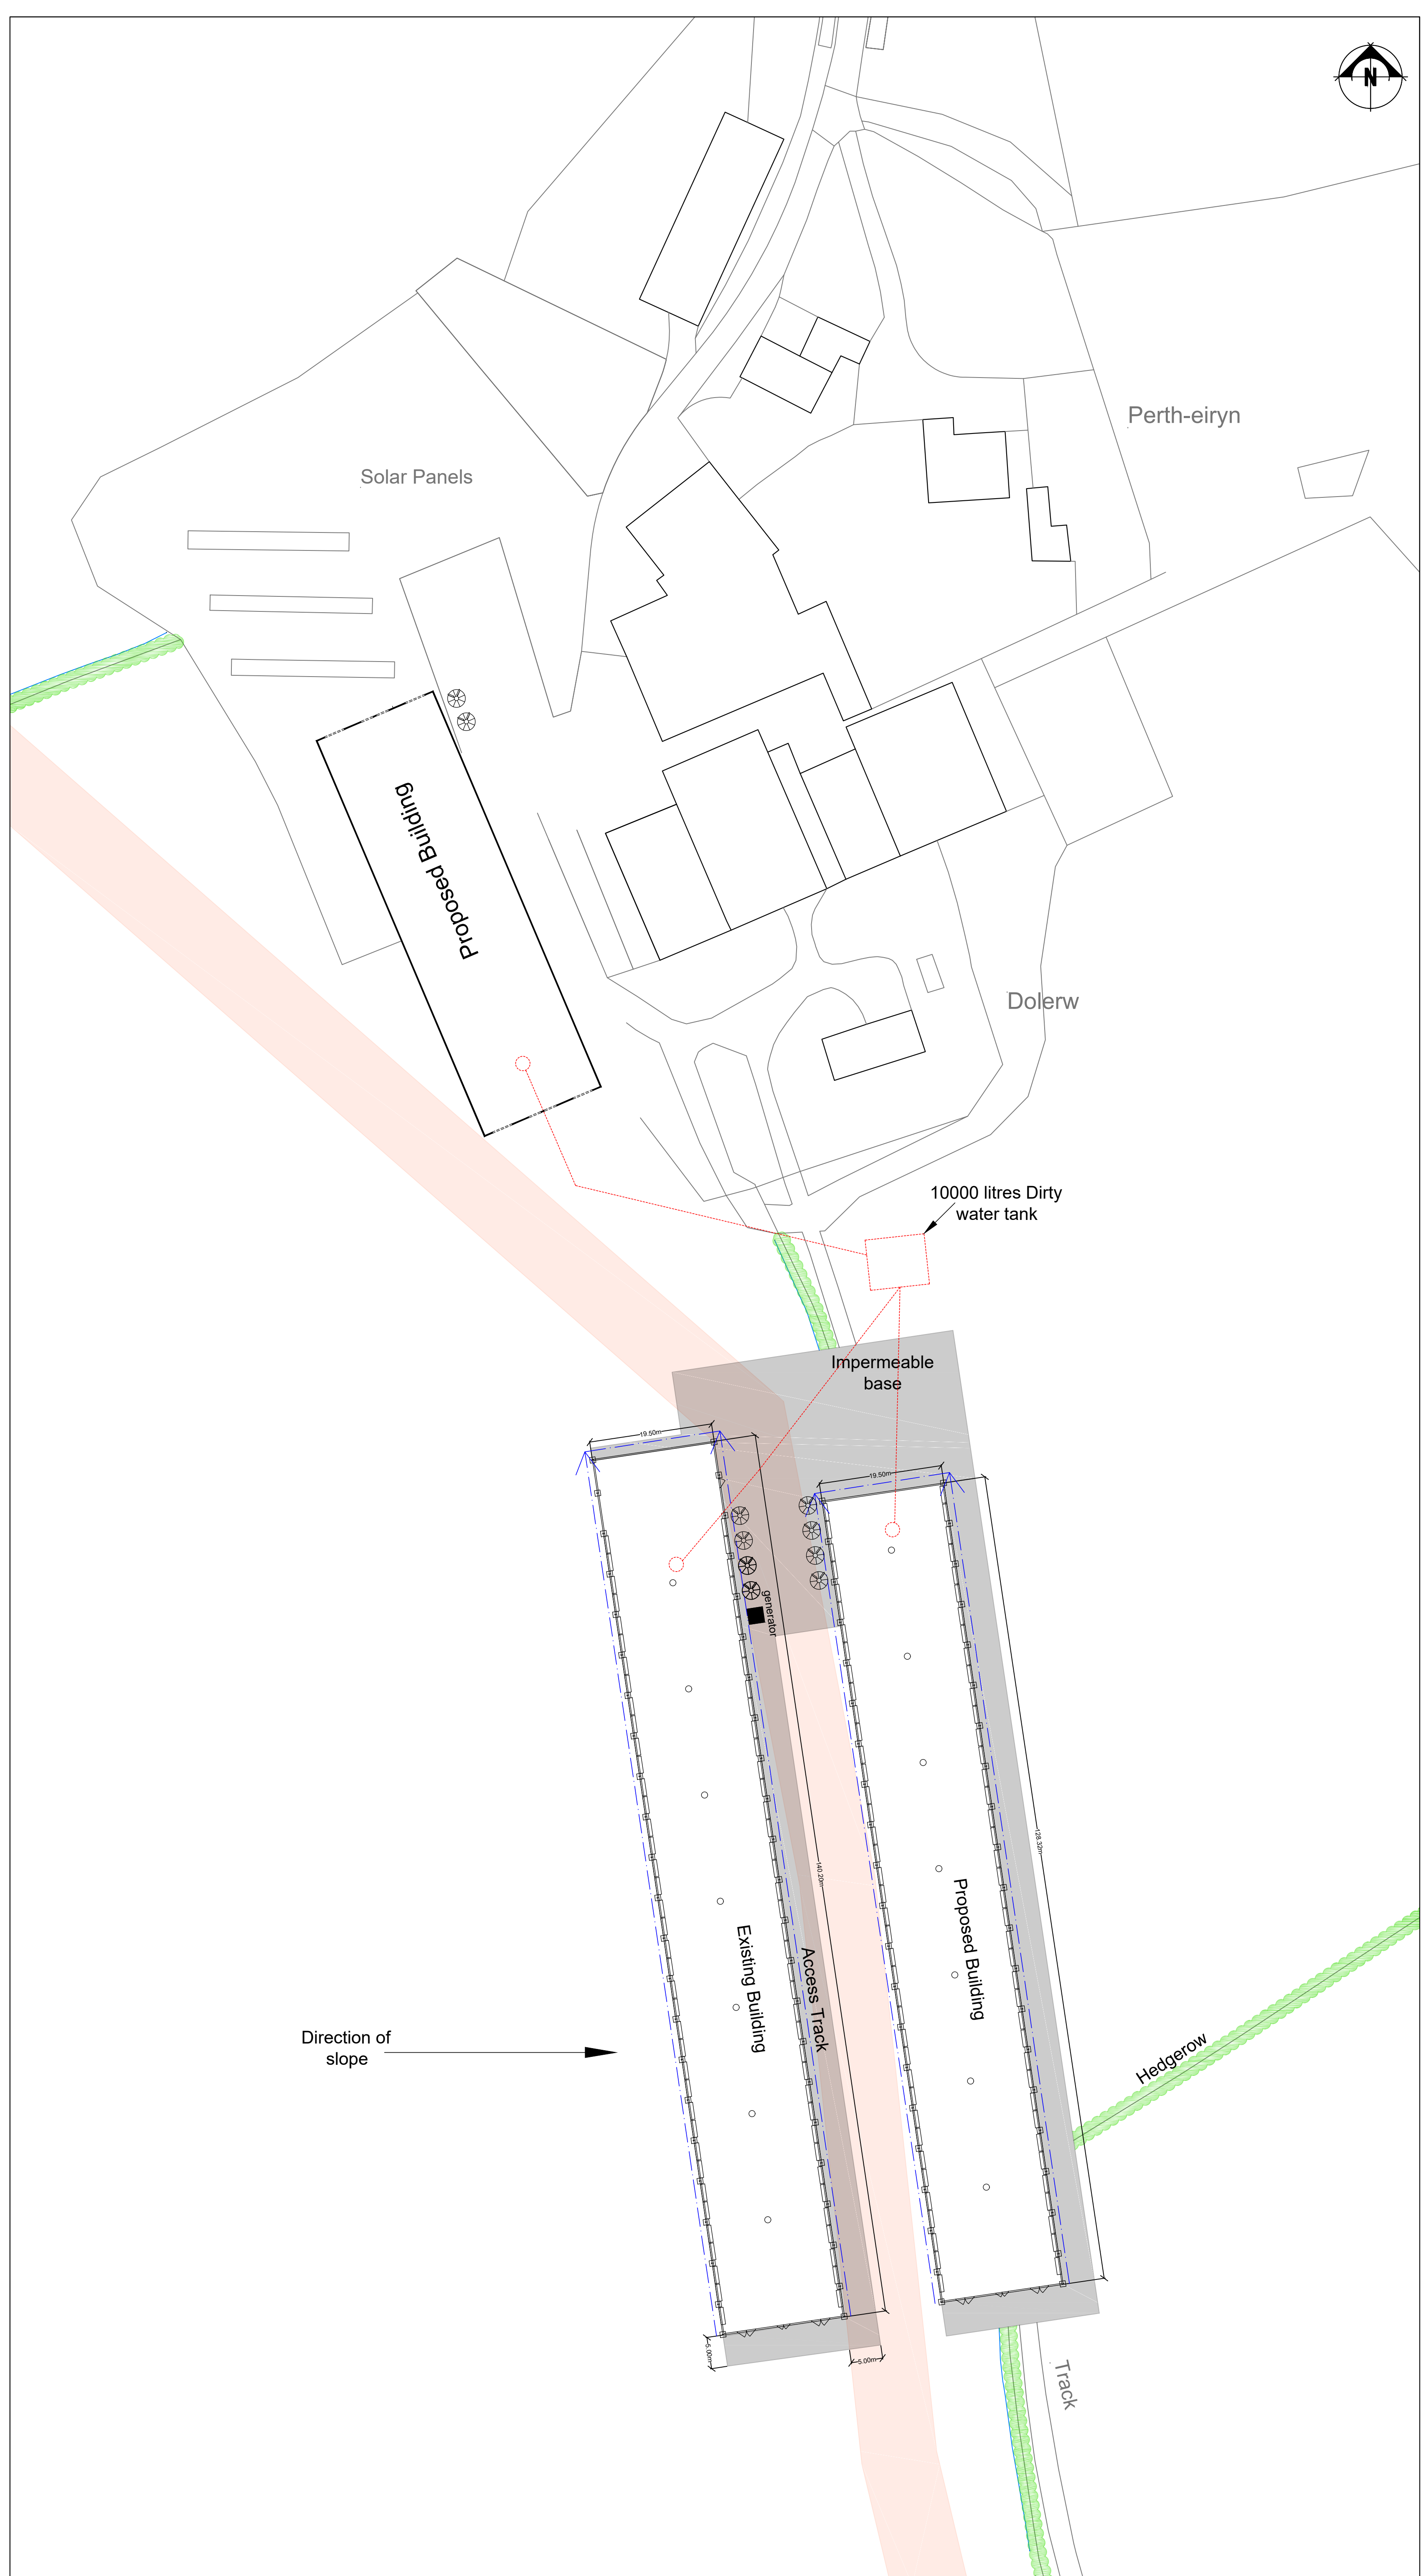

Rev	Description	Date	Dr by	App by
Original				



Residential - Agricultural - Commercial

Job	Proposed Free Range Egg Production Unit		
Title	Drainage Plan		
Location	Pertherin Farm Pontdolgoch Caersws Powys SY17 5NJ		
Client	RG & JA Hughes		
Scales	1:500 @ A1		
Drawing No.	RJC-MZ77-Hughes-06		
Drawn by	MZ	Date	02/08/2019

HOGSTOW HALL, MINSTERLEY
SHREWSBURY, SHROPSHIRE, SY5 0HZ
Tel: 01743 791336 Fax: 01743 792770
email: mail@rogerparry.net
Web address: www.rogerparry.net