



THIS DRAWING IS TO BE READ IN CONJUNCTION WITH ALL RELATED DRAWINGS. ALL DIMENSIONS MUST BE CHECKED AND VERIFIED ON SITE BEFORE COMMENCING ANY WORK OR PRODUCING SHOP DRAWINGS. THE ORIGINATOR SHOULD BE NOTIFIED IMMEDIATELY OF ANY DISCREPANCY. THIS DRAWING IS COPYRIGHT AND REMAINS THE PROPERTY ROGER PARRY & PARTNERS.


 Gas Pipeline

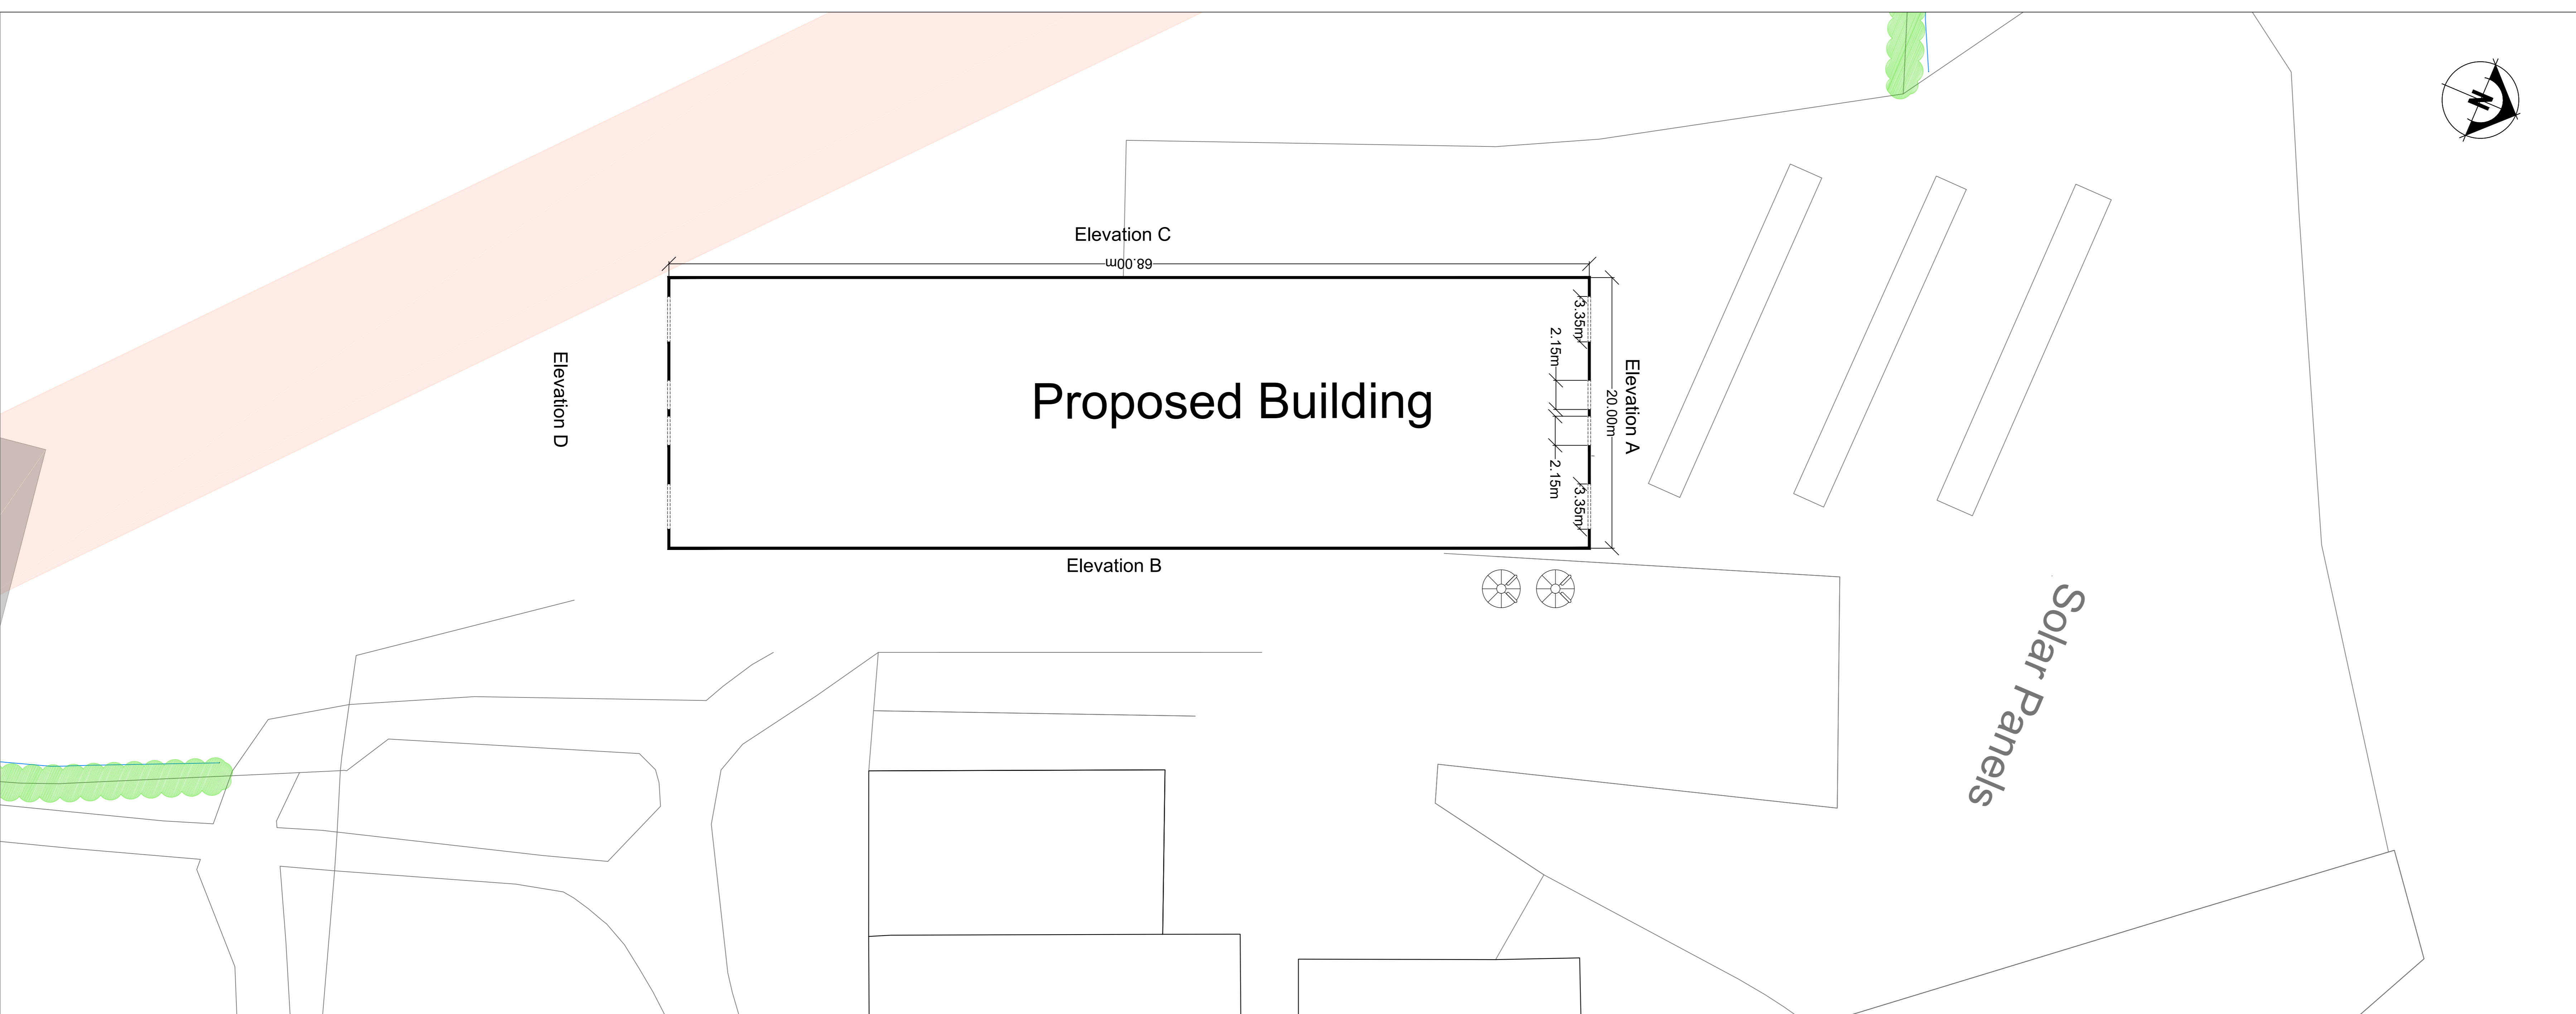

Scale: 1:200

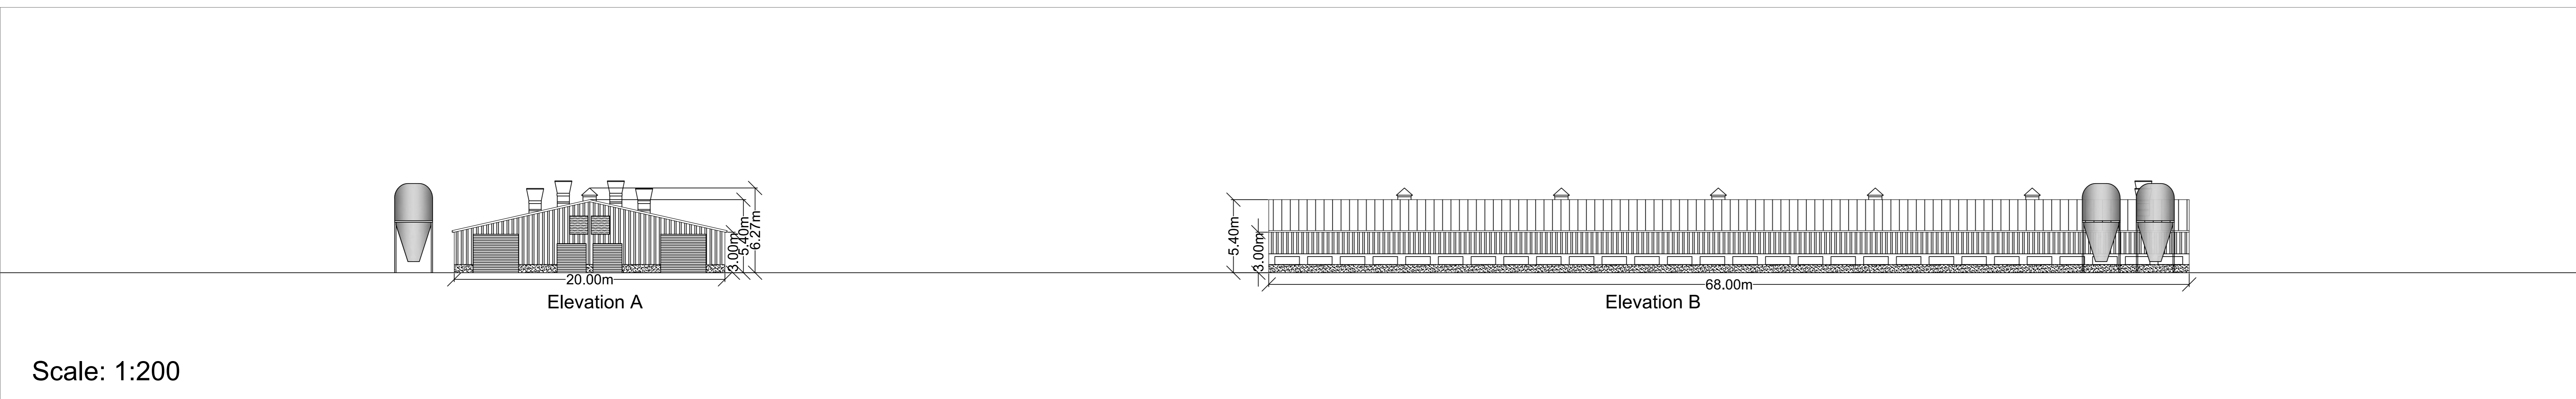

Scale: 1:200

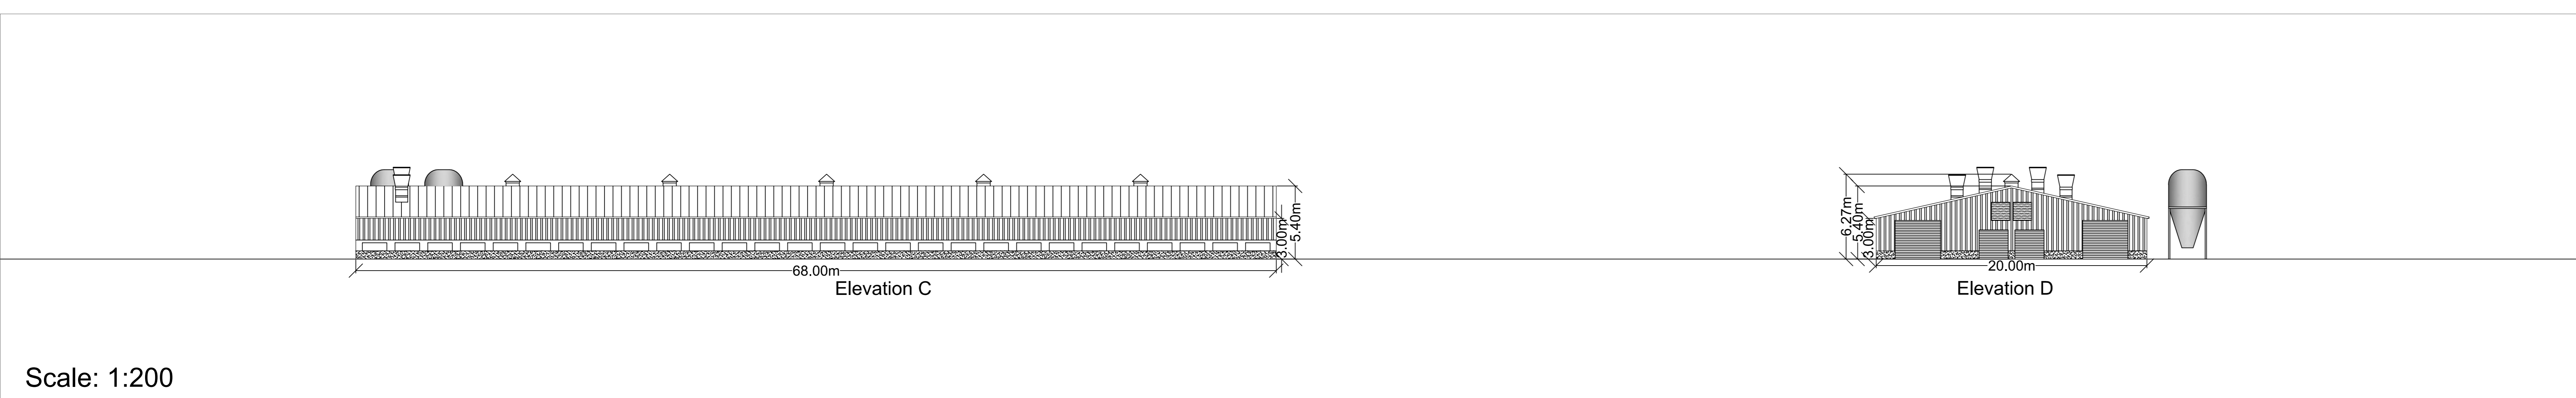

Scale: 1:200

Rev	Description	Date	Dr by	App by
Original				



Residential - Agricultural - Commercial	
Job	Proposed 16000 bird unit
Title	Proposed Elevations & Floor Plan
Location	Pertherin Farm Pontdolgoch Caersws Powys SY17 5NJ
Client	RG & JA Hughes
Scales	See Plan @ A0
Drawing No.	RJC-MZ77-Hughes-07
Drawn by	AZ
Date	02/08/2019

HOGSTOW HALL, MINSTERLEY
SHREWSBURY, SHROPSHIRE, SY5 0HZ
Tel: 01743 791336 Fax: 01743 792770
email: mail@rogerparry.net
Web address: www.rogerparry.net